


BILL OF MATERIALS

TAG	QTY	MFG/VNDR	PART #	DESCRIPTION
PANEL DEVICES:				
P-1	1	JCI	PAGA00001AC0	20"X24" PNL, NAE5510, XFMR, 5-PRT SW
P-1A	1	KELE	SC18126	18"X12"X6" ENCL. W/ PREFORATED BACK PNL
UPS-1	1	SOLA	SDU850	UPS, DIN, 850VA/510W, 120VACIN/OUT, 2 MIN
FIELD DEVICES:				
RPTR-1	1	ACROMAG	4683-TTM-1	RS-485 REPEATER, 115VAC

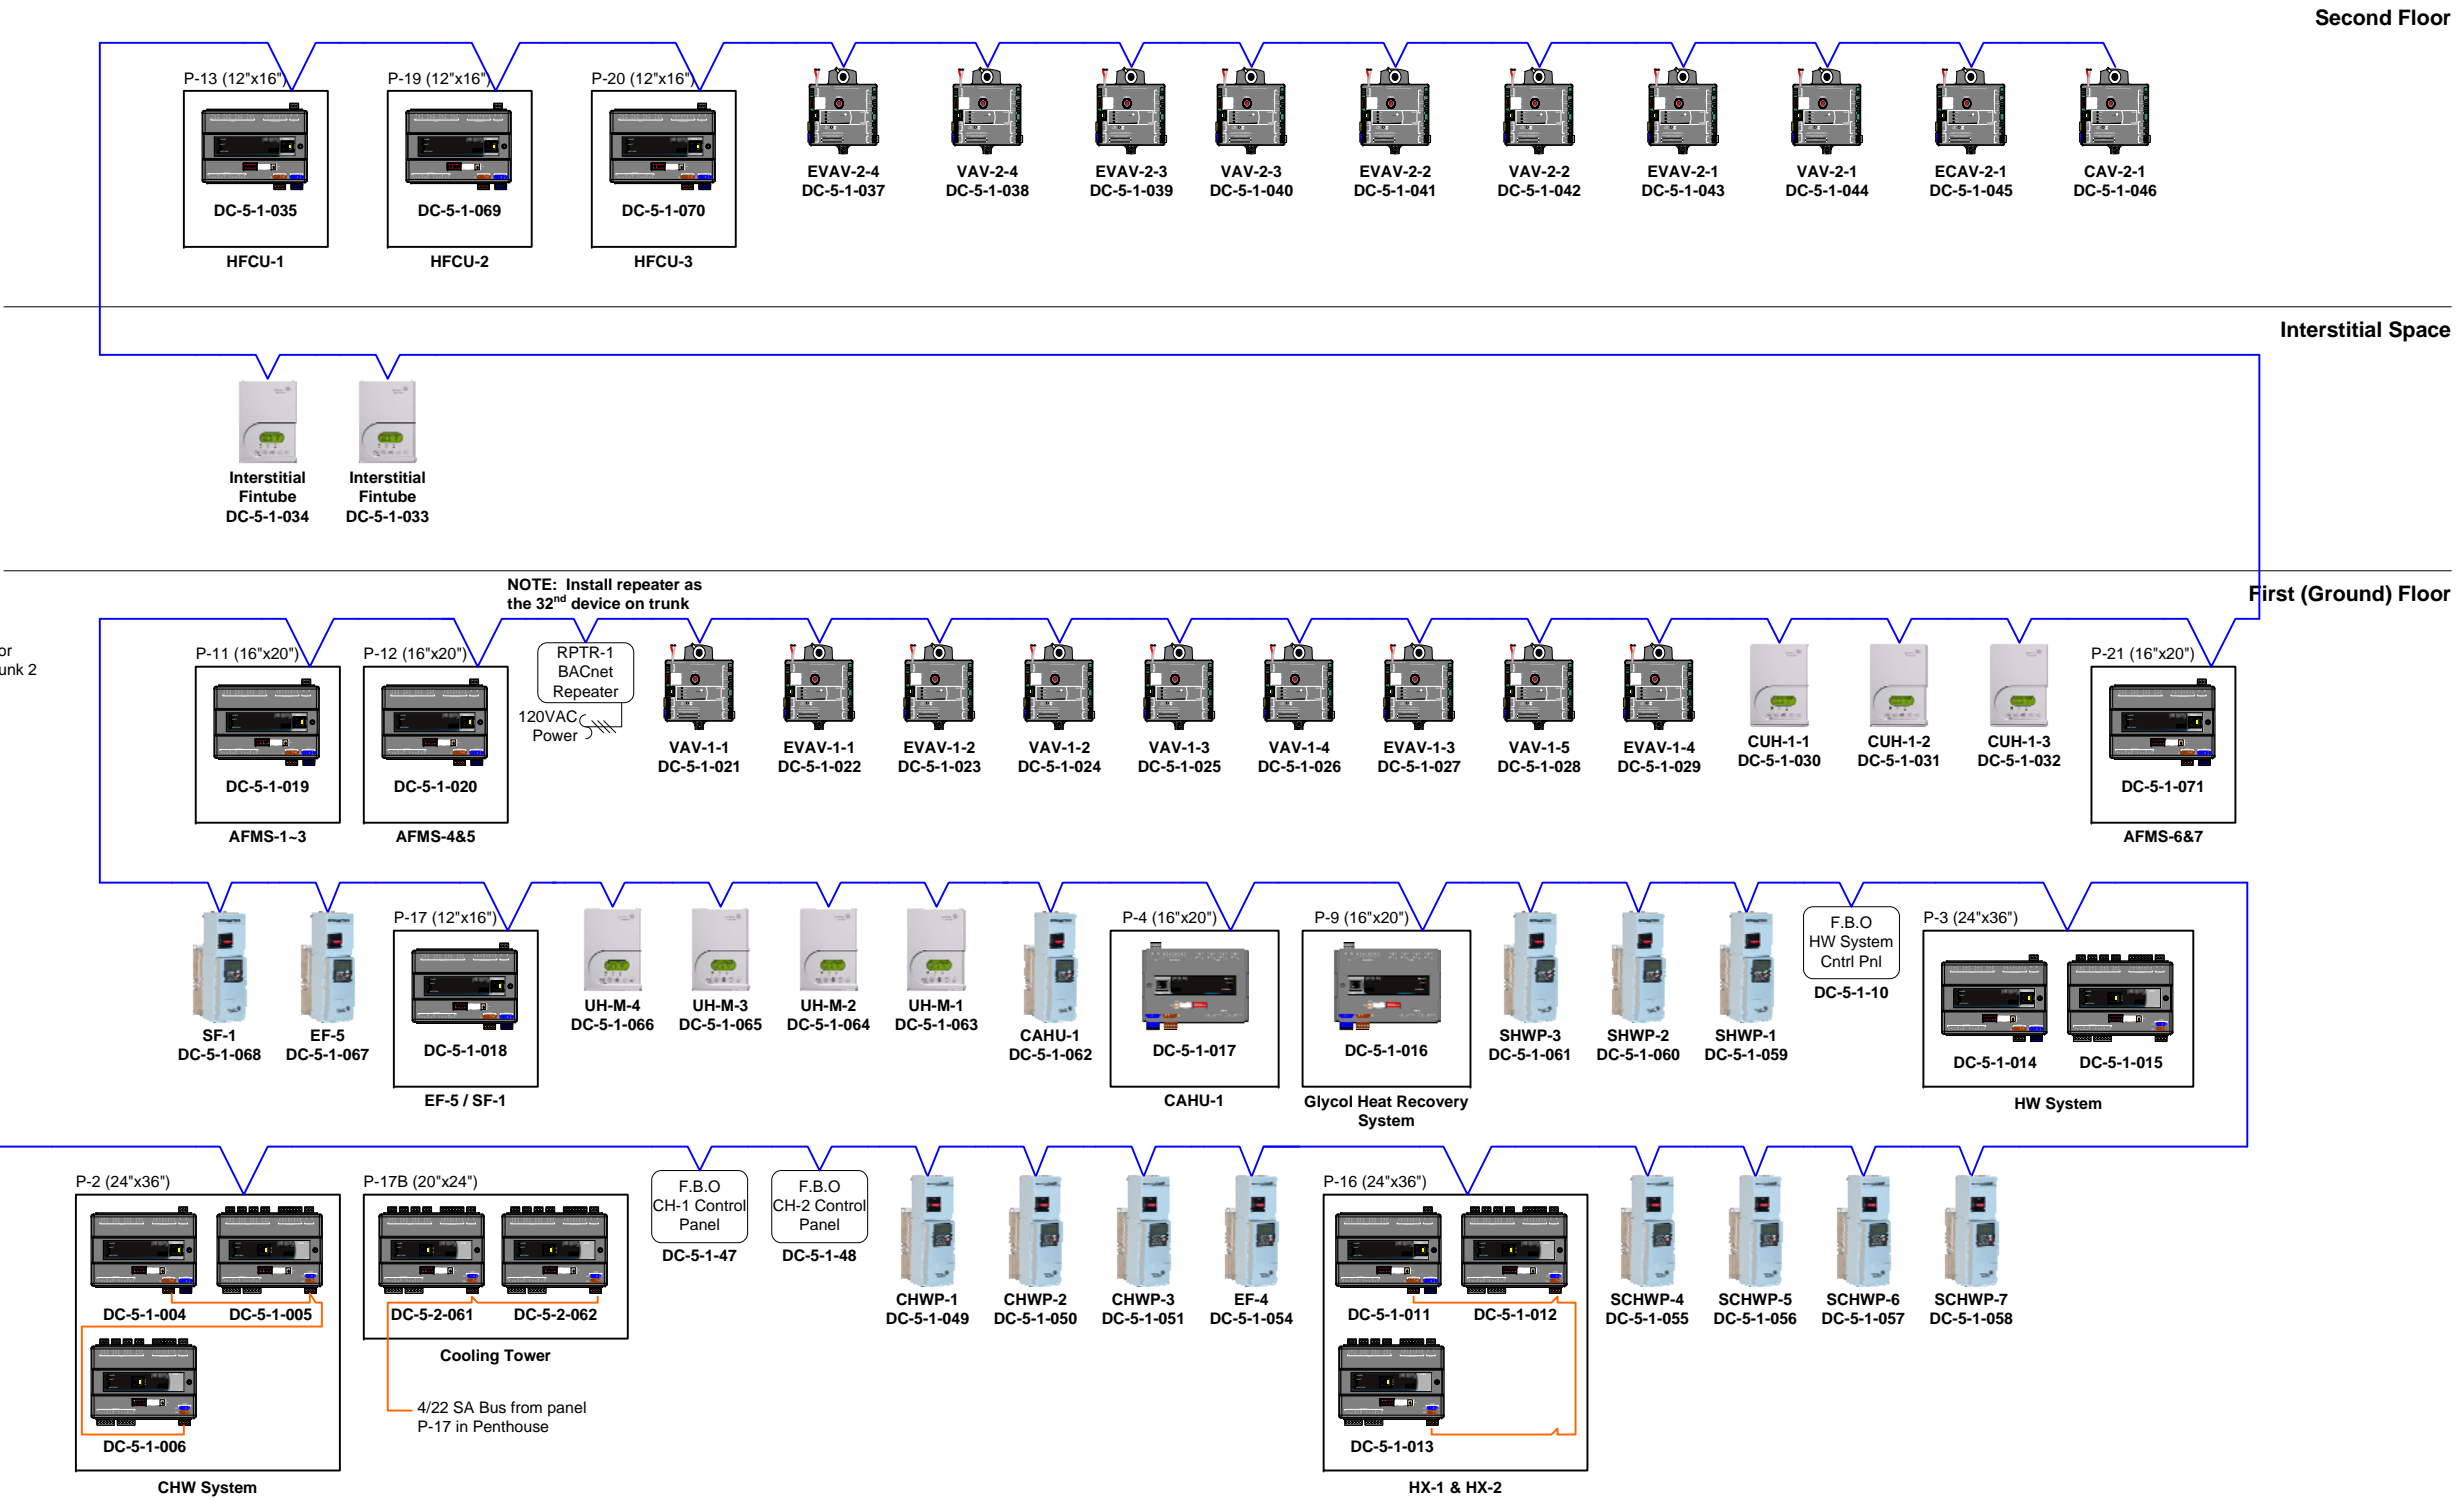

Communications Riser Trunk 1

NO.	Date	Revision Record

EMC SERVICES

116 Budlong Road
Cranston, Rhode Island 02920

Mechanical Contractor

Address
City, State


Customer

Address
City, State

JOB NUMBER: ##### SCALE: NTS DRAWN BY: P. Braga APPROVED BY: W. Roskowski


FILE: Communications Riser.vsd

DATE: 04/13/12 DRAWING NUMBER: **ATC-1**

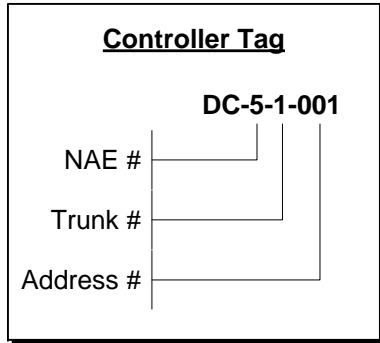

BILL OF MATERIALS

TAG	QTY	MFG/VNDR	PART #	DESCRIPTION
FIELD DEVICES:				
RPTR-2	1	ACROMAG	4683-TTM-1	RS-485 REPEATER, 115VAC

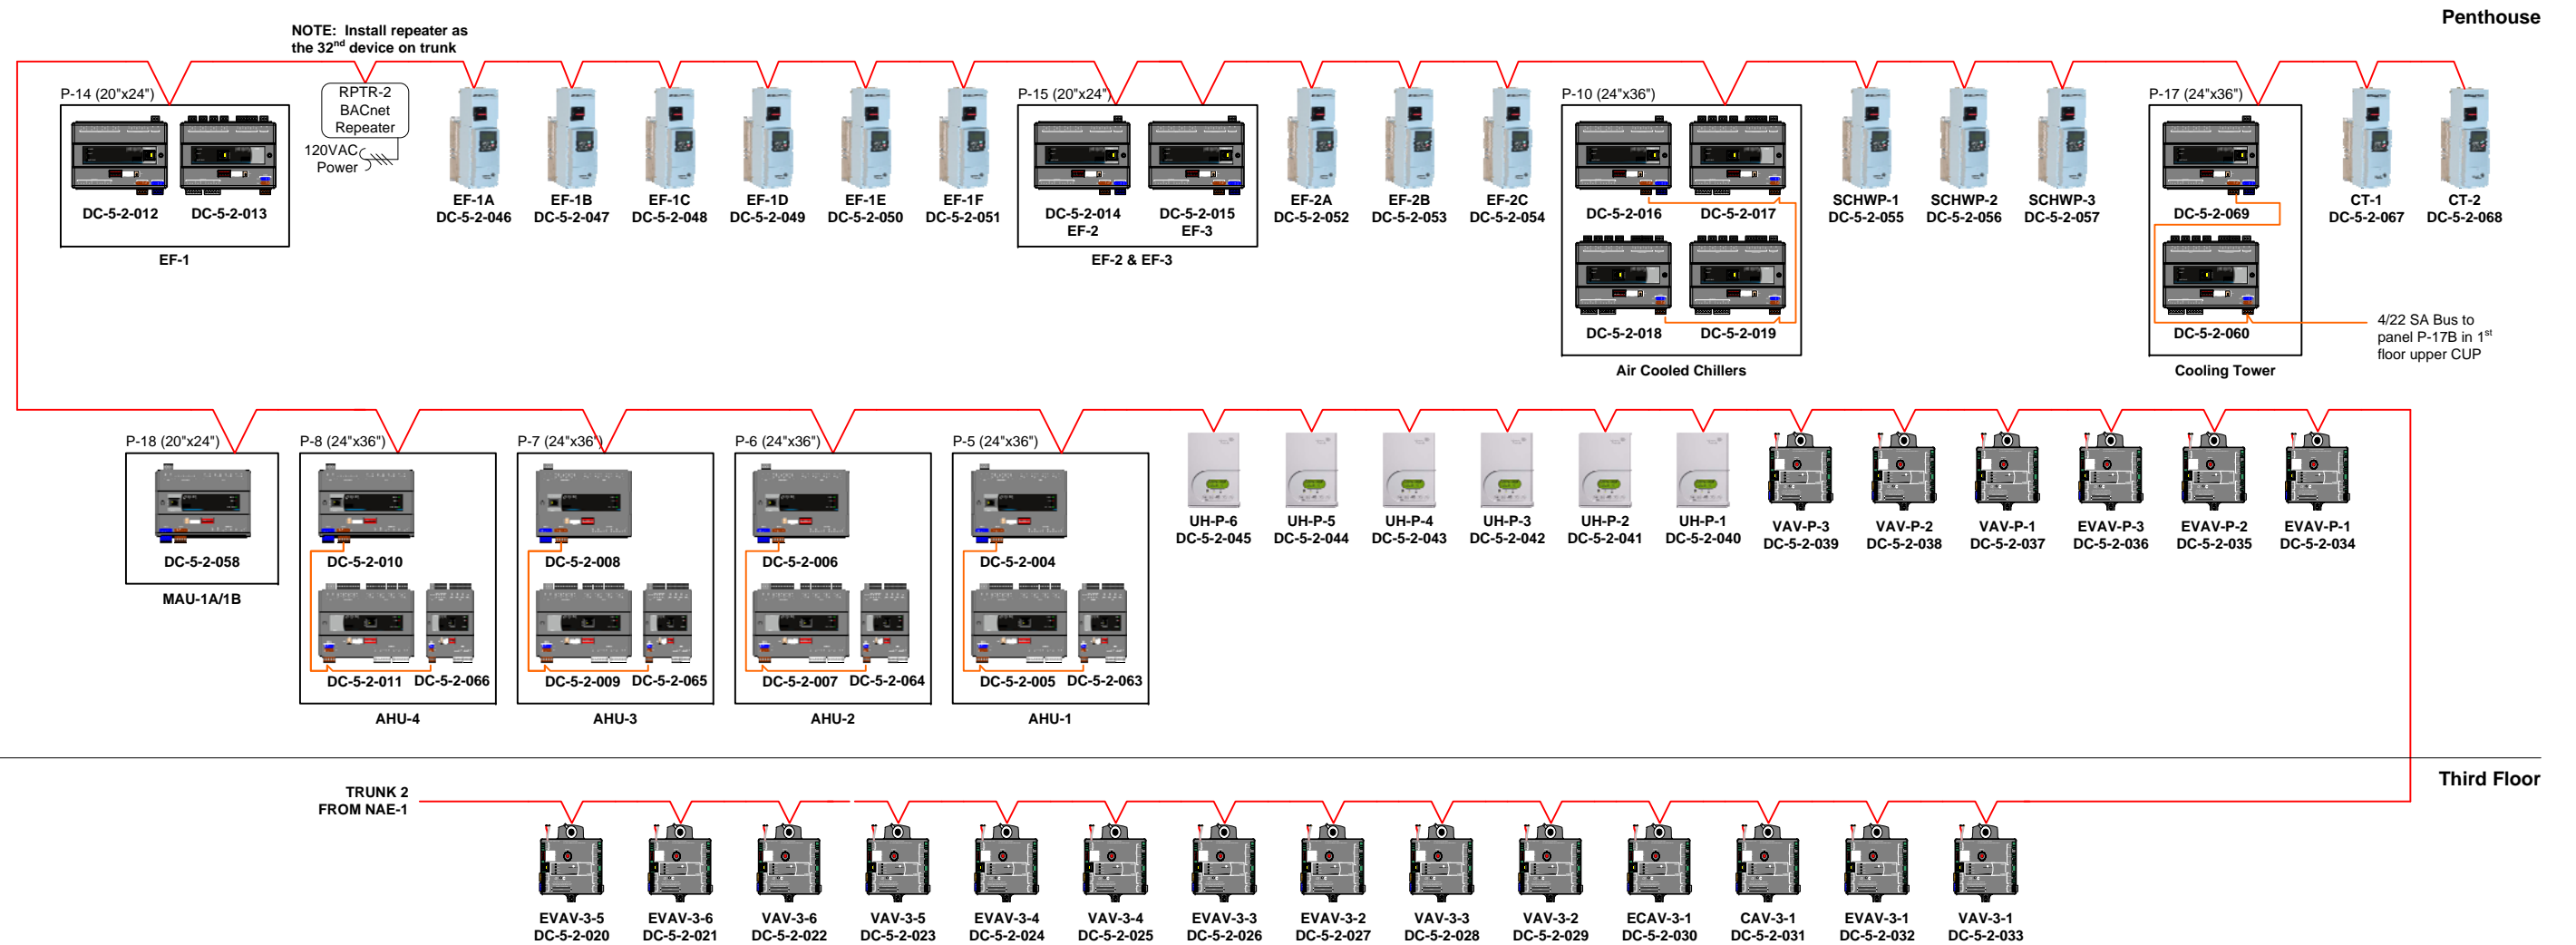

Communications Riser Trunk 2

NO.	Date	Revision Record

EMC SERVICES
116 Budlong Road
Cranston, Rhode Island 02920

Mechanical Contractor
Address
City, State

Customer
Address
City, State

JOB NUMBER: ####	SCALE: NTS	DRAWN BY: P. Braga
FILE: Communications Riser.vsd		APPROVED BY: W. Roskowski
DATE: 04/13/12	DRAWING NUMBER: ATC-1A	